


GRAPHIC SCALE: 1/8" = 1'-0"
 GRAPHIC SCALE: 1/16" = 1'-0"
 GRAPHIC SCALE: 3/32" = 1'-0"
 GRAPHIC SCALE: 1/8" = 1'-0"
 GRAPHIC SCALE: 3/16" = 1'-0"
 GRAPHIC SCALE: 1/4" = 1'-0"
 GRAPHIC SCALE: 3/8" = 1'-0"
 GRAPHIC SCALE: 1/2" = 1'-0"
 GRAPHIC SCALE: 3/4" = 1'-0"
 GRAPHIC SCALE: 1" = 1'-0"
 11/02/2025 5:44:53 PM Autodesk Docs | 1080 Multi-Agency Law Enforcement Training Academy (MATE) PROJECT_05 HOUSING AND DINING_FS_NNAN_22-14

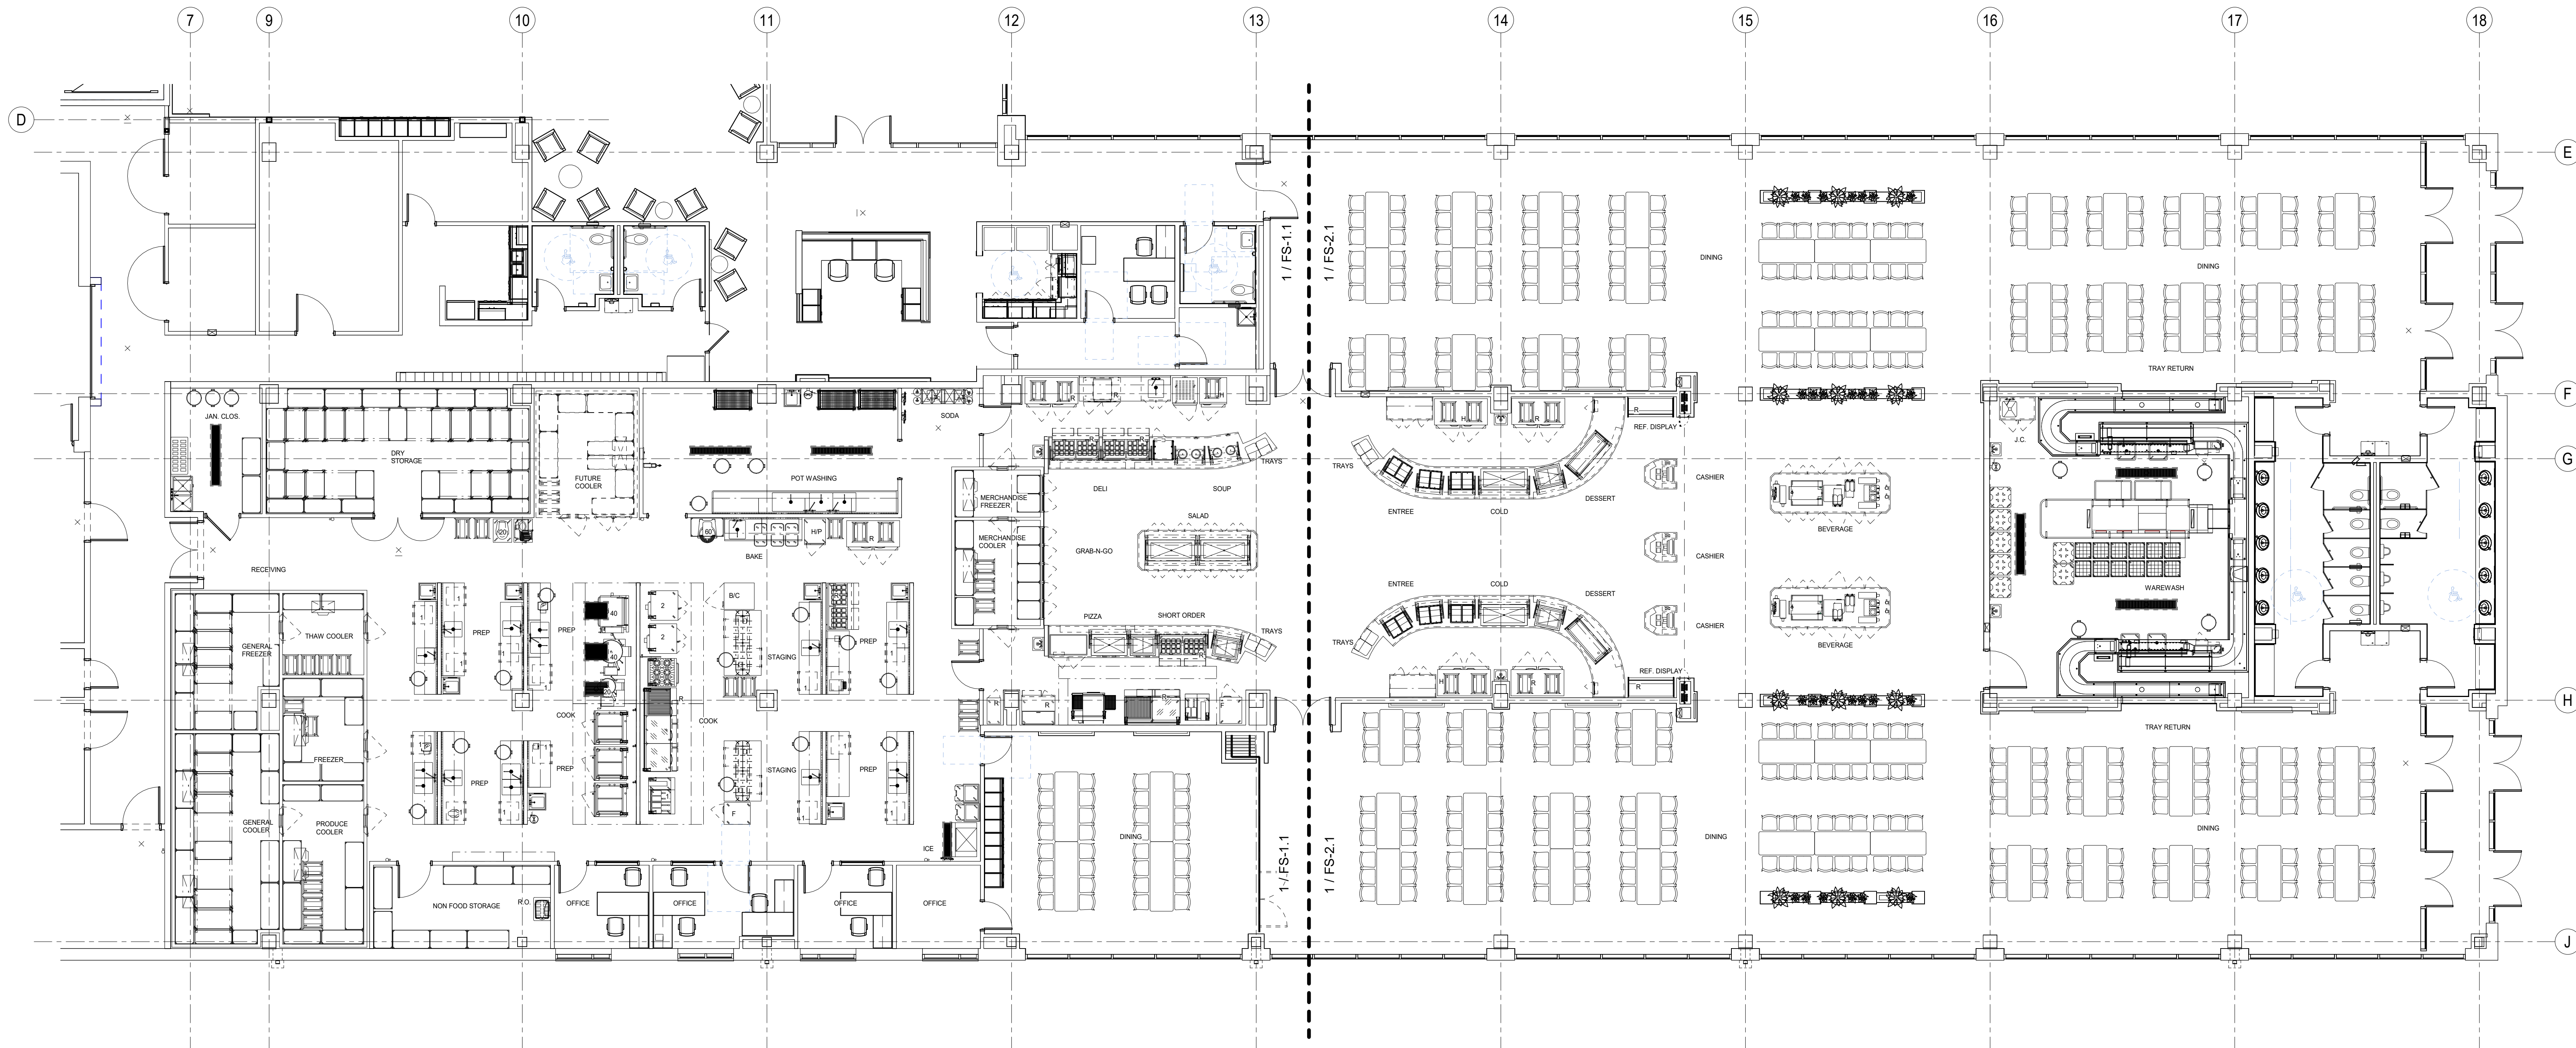

1 OVERALL KITCHEN / SERVERY / WAREWASH EQUIPMENT PLAN
 1/8" = 1'-0"

FOOD SERVICE SHEET INDEX	
NUMBER	NAME
FS-0.1	OVERALL KITCHEN / SERVERY / WAREWASH EQUIPMENT PLAN
FS-0.2	SCHEDULE OF EQUIPMENT
FS-1.1	KITCHEN AND SERVERY EQUIPMENT PLAN
FS-1.2	KITCHEN AND SERVERY PLUMBING PLAN
FS-1.3	KITCHEN AND SERVERY ELECTRICAL PLAN
FS-1.4	KITCHEN AND SERVERY SLAB PENETRATION & SODA CONDUIT PLAN
FS-1.5	KITCHEN AND SERVERY SPECIAL CONDITIONS PLAN
FS-1.6	KITCHEN AND SERVERY REFRIGERATION PLAN
FS-2.1	SERVERY AND WAREWASH EQUIPMENT PLAN
FS-2.2	SERVERY AND WAREWASH PLUMBING PLAN
FS-2.3	SERVERY AND WAREWASH ELECTRICAL PLAN
FS-2.4	SERVERY AND WAREWASH SLAB PENETRATION & SODA CONDUIT PLAN
FS-2.5	SERVERY AND WAREWASH SPECIAL CONDITIONS PLAN
FS-3.1	ROOF REMOTE CONDENSING UNIT EQUIPMENT & ELECTRICAL PLAN
FS-3.2	ROOF REMOTE CONDENSING UNIT REFRIGERATION & SPECIAL CONDITIONS PLAN
FS-4.1	MEP SCHEDULES
FS-4.2	MEP NOTES AND SYMBOLS
FS-4.3	DETAILS / WALL BACKING DETAILS
FS-4.4	ADA DETAILS
FS-5.1	ISOMETRIC AND ELEVATIONS VIEWS
FS-5.2	ISOMETRIC AND ELEVATIONS VIEWS
FS-5.3	ISOMETRIC AND ELEVATIONS VIEWS
FS-5.4	ISOMETRIC AND ELEVATIONS VIEWS
FS-5.5	ISOMETRIC AND ELEVATIONS VIEWS

FOOD SERVICE SHEET INDEX	
NUMBER	NAME
FS-5.6	ISOMETRIC AND ELEVATIONS VIEWS
FS-5.7	ISOMETRIC AND ELEVATIONS VIEWS
FS-5.8	ISOMETRIC AND ELEVATIONS VIEWS
FS-6.1	HOOD DRAWING 1 OF 13 CAPTIVE AIRE DOCUMENTS
FS-6.2	HOOD DRAWING 2 OF 13 CAPTIVE AIRE DOCUMENTS
FS-6.3	HOOD DRAWING 3 OF 13 CAPTIVE AIRE DOCUMENTS
FS-6.4	HOOD DRAWING 4 OF 13 CAPTIVE AIRE DOCUMENTS
FS-6.5	HOOD DRAWING 5 OF 13 CAPTIVE AIRE DOCUMENTS
FS-6.6	HOOD DRAWING 6 OF 13 CAPTIVE AIRE DOCUMENTS
FS-6.7	HOOD DRAWING 7 OF 13 CAPTIVE AIRE DOCUMENTS
FS-6.8	HOOD DRAWING 8 OF 13 CAPTIVE AIRE DOCUMENTS
FS-6.9	HOOD DRAWING 9 OF 13 CAPTIVE AIRE DOCUMENTS
FS-6.10	HOOD DRAWING 10 OF 13 CAPTIVE AIRE DOCUMENTS
FS-6.11	HOOD DRAWING 11 OF 13 CAPTIVE AIRE DOCUMENTS
FS-6.12	HOOD DRAWING 12 OF 13 CAPTIVE AIRE DOCUMENTS
FS-6.13	HOOD DRAWING 13 OF 13 CAPTIVE AIRE DOCUMENTS
FS-7.1	CHAMPION FLIGHT TYPE DISH MACHINE
FS-7.2	SOLEWARE HANDLING SYSTEM 1 OF 2 CHAMPION DOCUMENTS
FS-7.3	SOLEWARE HANDLING SYSTEM 2 OF 2 CHAMPION DOCUMENTS
FS-8.1	COOLER DRAWING 1 OF 2 KOLPAK DOCUMENTS FOR ITEM #12
FS-8.2	COOLER DRAWING 2 OF 2 KOLPAK DOCUMENTS FOR ITEM #12
FS-8.3	COOLER DRAWING 1 KOLPAK DOCUMENT FOR ITEM #71
FS-8.4	COOLER DRAWING 1 OF 2 KOLPAK DOCUMENTS FOR ITEM #163
FS-8.5	COOLER DRAWING 2 OF 2 KOLPAK DOCUMENTS FOR ITEM #163

THIS DRAWING INDICATES THE GENERAL EXTENT OF THE WORK AND IS NOT INTENDED TO INDICATE OR DESCRIBE ANY AND ALL WORK REQUIRED FOR THE FULL PERFORMANCE AND COMPLETION OF THE REQUIREMENTS OF THE CONTRACT DOCUMENTS.